

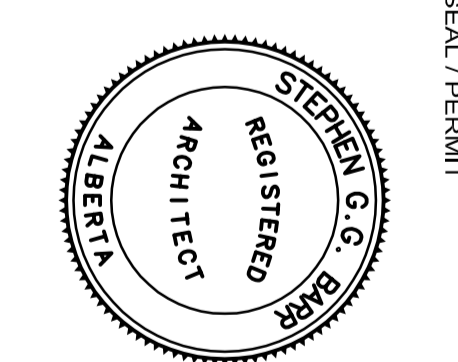
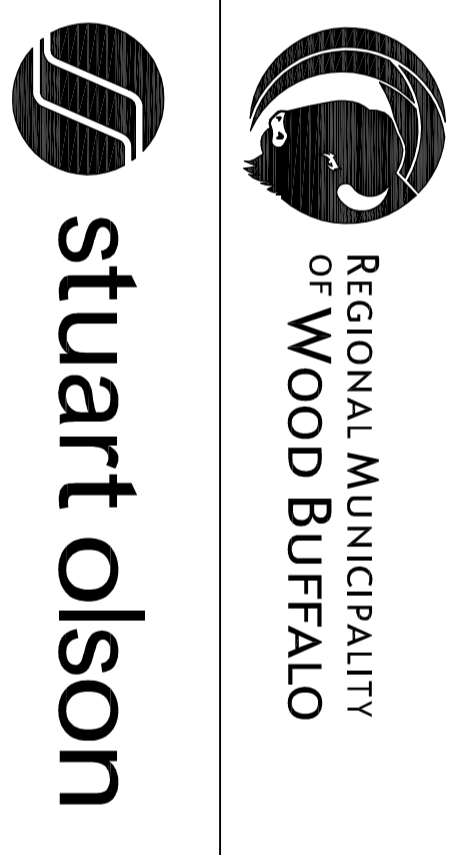


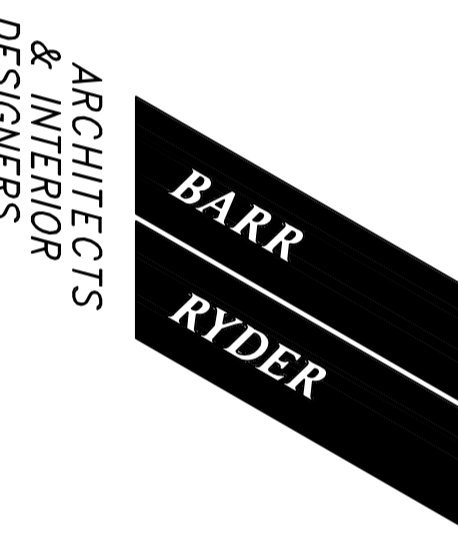

MACDONALD ISLAND REDEVELOPMENT PROJECT FORT McMURRAY, ALBERTA

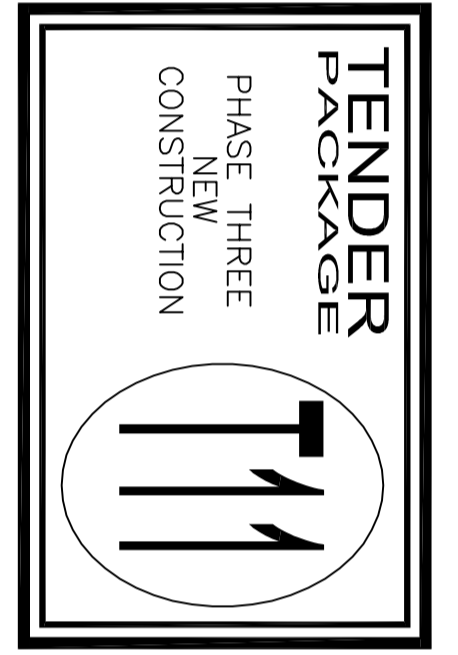

REVISIONS


NO	DATE	DESCRIPTION
1	02/02/07	ISSUED FOR TENDER / CONSTRUCTION

PROJECT NORTH

KEYPLAN

MAIN FLOOR REFLECTED CEILING PLAN - TILE 6

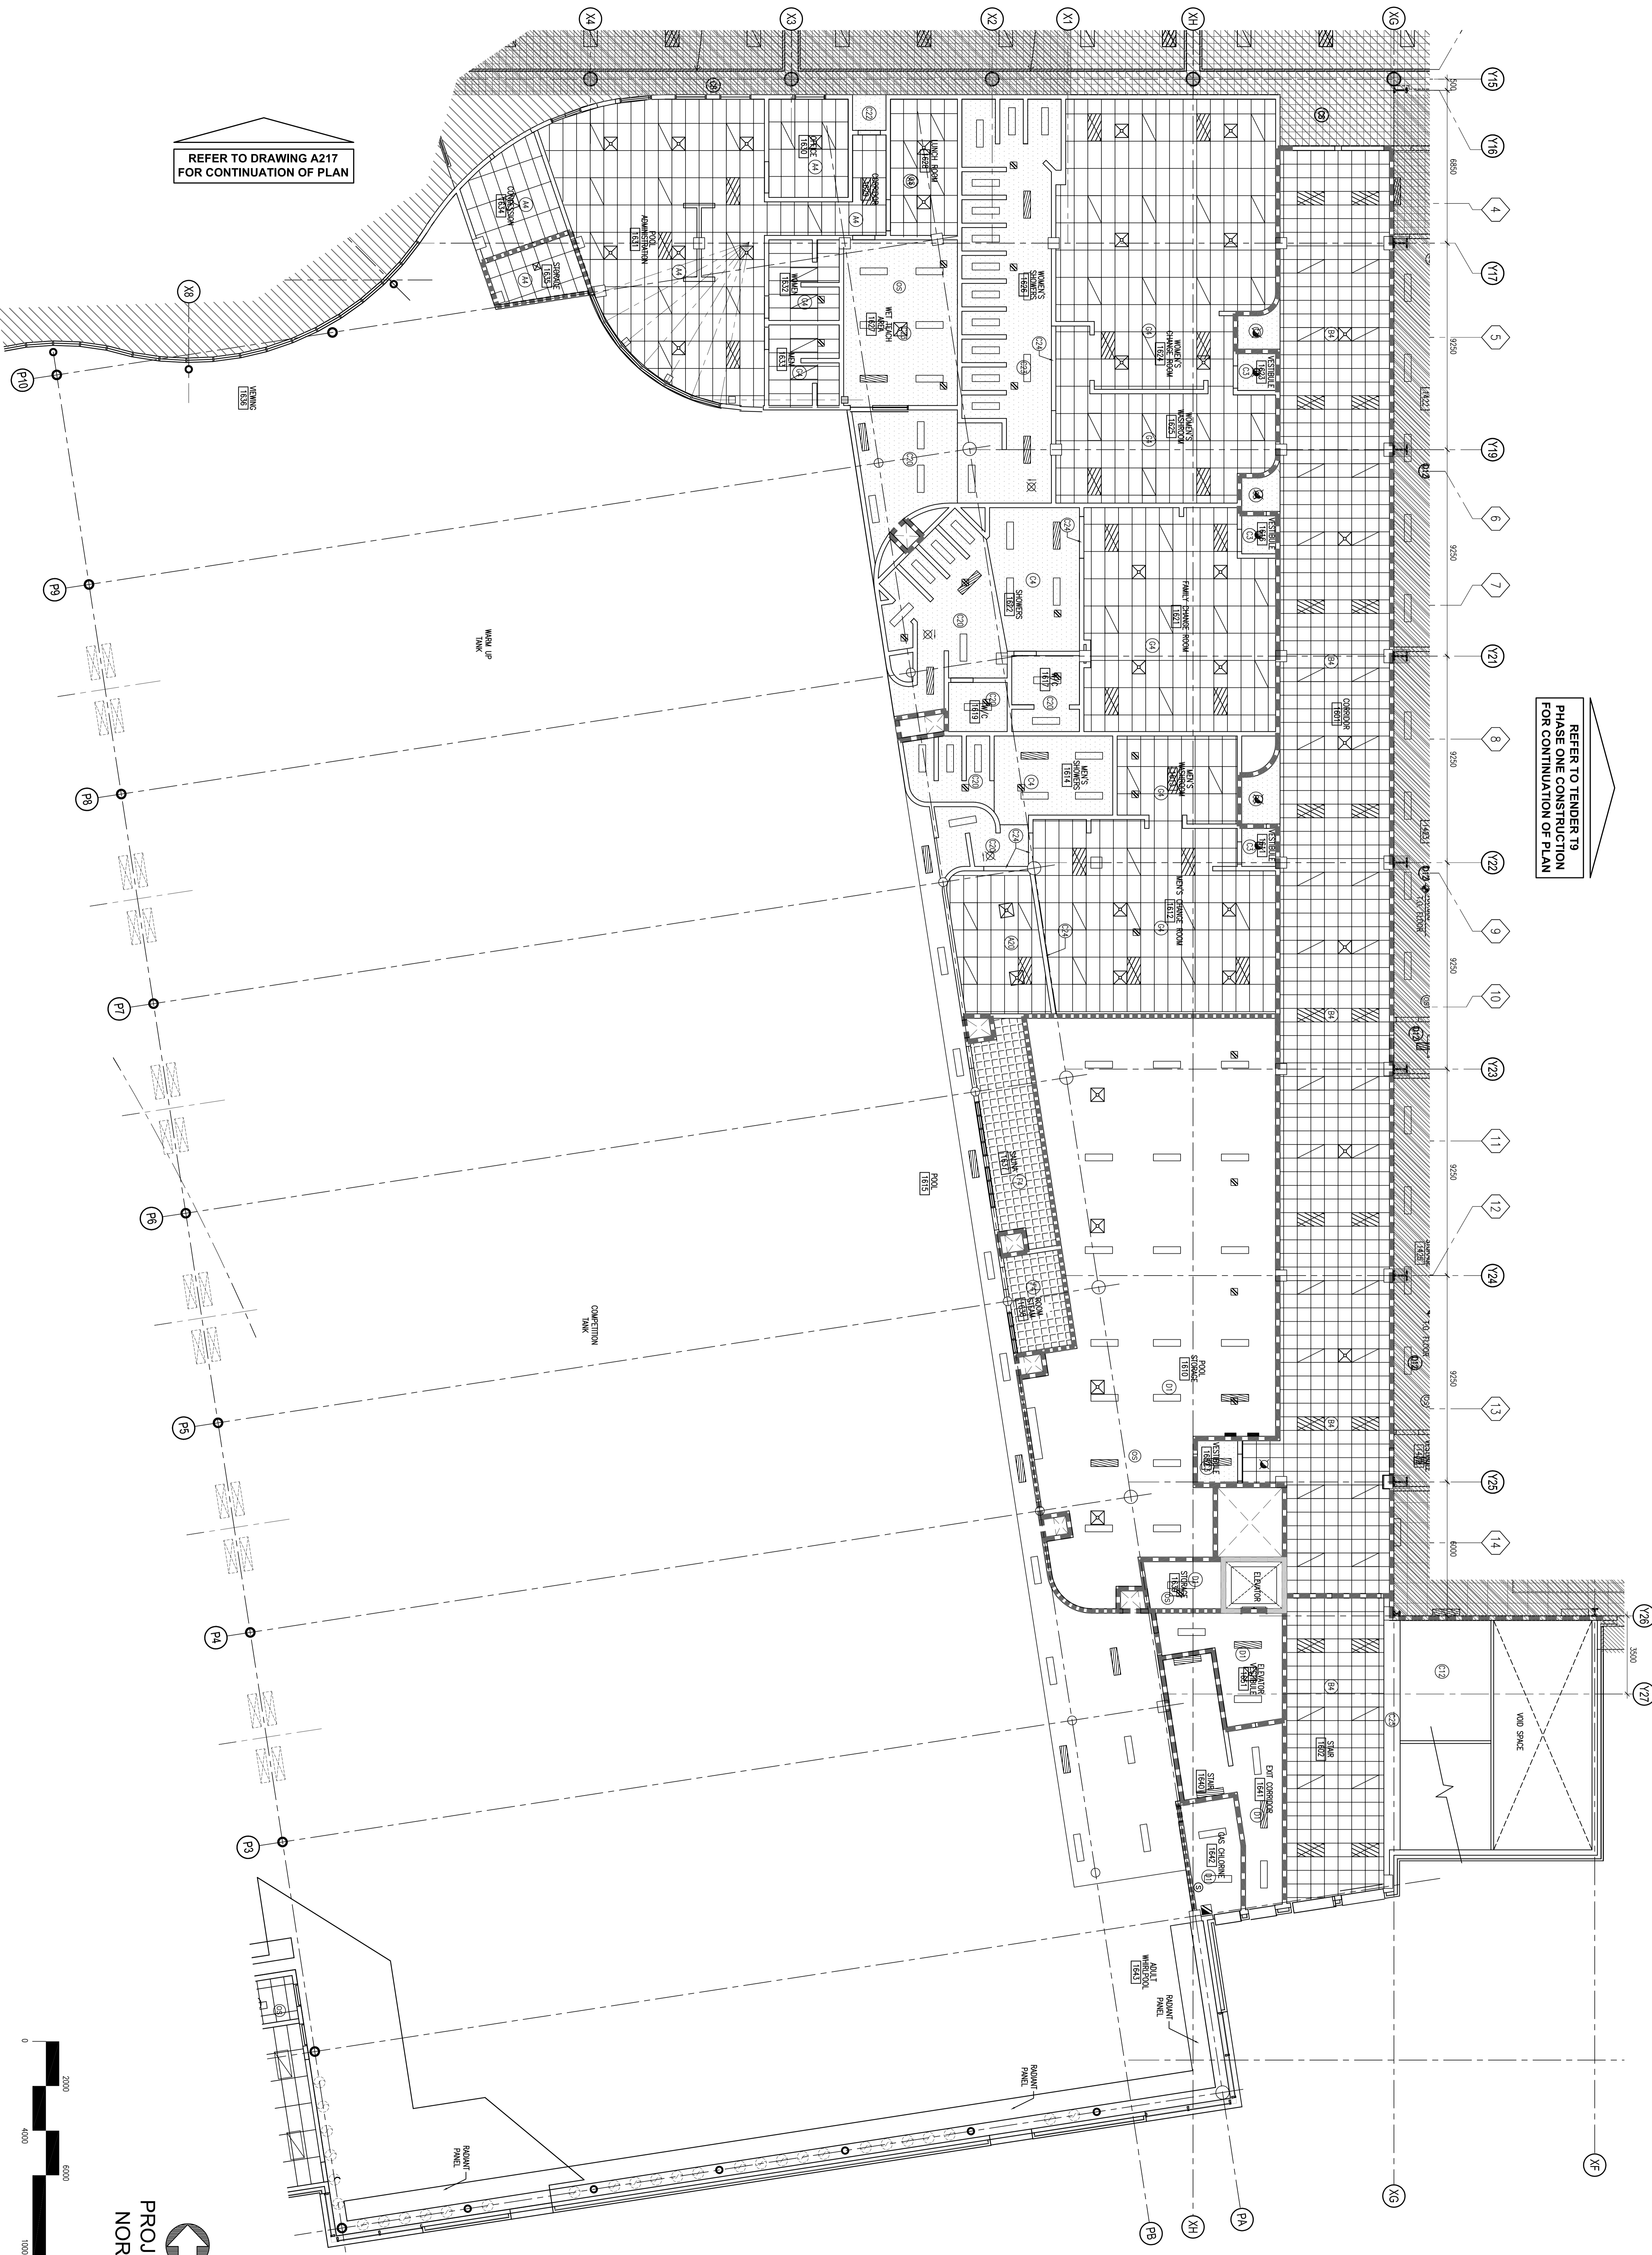


 


 



 
 
 
 
 

 
 
 
 
 
 
 
 
 
 
 

Project No: 25036
Scale: 1/8" = 1'-0"
Date: 02/20/07
Sheet No: A716



REFER TO DRAWING A217 FOR CONTINUATION OF PLAN

REFER TO TENDER TO PHASE ONE CONSTRUCTION FOR CONTINUATION OF PLAN

 


 
 

 










 


 




REFLECTED CEILING PLAN LEGEND:

-  CEILING STRUCTURE ABOVE FINISHED FLOOR
-  CEILING STRUCTURE BELOW FINISHED FLOOR
-  SUSPENDED 1-BAR & ACOUSTIC CEILING TILE (6x7)
-  SUSPENDED 1-BAR & ACOUSTIC CEILING TILE (5x7)
-  GYPSUM BOARD
-  EXPOSED STRUCTURAL FRAME
-  EXPOSED CEILING STRUCTURE
-  SUSPENDED 1-BAR & ACOUSTIC CEILING TILE (5x6)
-  GYPSUM BOARD CEILING
-  U/S STRUCTURE
-  2"
-  3"
-  4"
-  5"
-  6"
-  8"
-  10"
-  11"
-  13"
-  15"
-  18"
-  19"
-  20"
-  21"
-  23"
-  24"
-  25"
-  26"

GENERAL NOTES:

- WHERE SHOWN, SUSPENDED CEILING LIGHTS SHALL BE INSTALLED AT THE FOLLOWING SPACING: 12" ON CENTER. REFER TO MECHANICAL AND ELECTRICAL DRAWINGS FOR IDENTIFICATION.
- CEILING HEIGHTS SHOWN ON MAIN FLOOR ARE MEASURED FROM TOP OF MAIN FLOOR CONCRETE SLAB. CEILING HEIGHTS ON SECOND FLOOR ARE MEASURED FROM TOP OF SECOND FLOOR SLAB.
- REFER TO MECHANICAL AND ELECTRICAL DRAWINGS FOR IDENTIFICATION.

SYMBOLS LEGEND:

-  610 x 122mm RECESSED FLUORESCENT LIGHT
-  305 x 122mm RECESSED FLUORESCENT LIGHT
-  305 x 122mm SURFACE MOUNTED FLUORESCENT LIGHT
-  SURFACE MOUNTED FLUORESCENT TUBE
-  RECESSED LUMINAIRE
-  MECHANICAL SUPPLY OUTLETS
-  MECHANICAL WALL DIFFUSER
-  MECHANICAL RETURN AIR GRILLE
-  MECHANICAL GRILLE
-  BRANCH DUCT TAKE OFF
-  SUPPLY OR OUTDOOR AIR DUCT UP
-  RETURN OR EXHAUST AIR DUCT DOWN
-  RETURN OR EXHAUST AIR DUCT UP
-  TURNING VANES
-  DAMPER
-  FIRE DAMPER
-  ROOF FAN - EXHAUST AIR
-  SUPPLY AIR GRILLE OR DIFFUSER
-  RETURN OR EXHAUST AIR GRILLE
-  STANDARD PENDANT SPRINKLER HEAD
-  UPRIGHT & PENDANT SPRINKLER HEADS
-  SPECIAL SPRINKLER HEAD
-  FIRE DEPT. SAMPLER CONNECTION
-  FIRE EXTINGUISHER
-  FLOOR DRAIN