


NORTH

X2  
X3  
X4  
X5  
X6  
X7  
X8  
X9  
X10  
X11

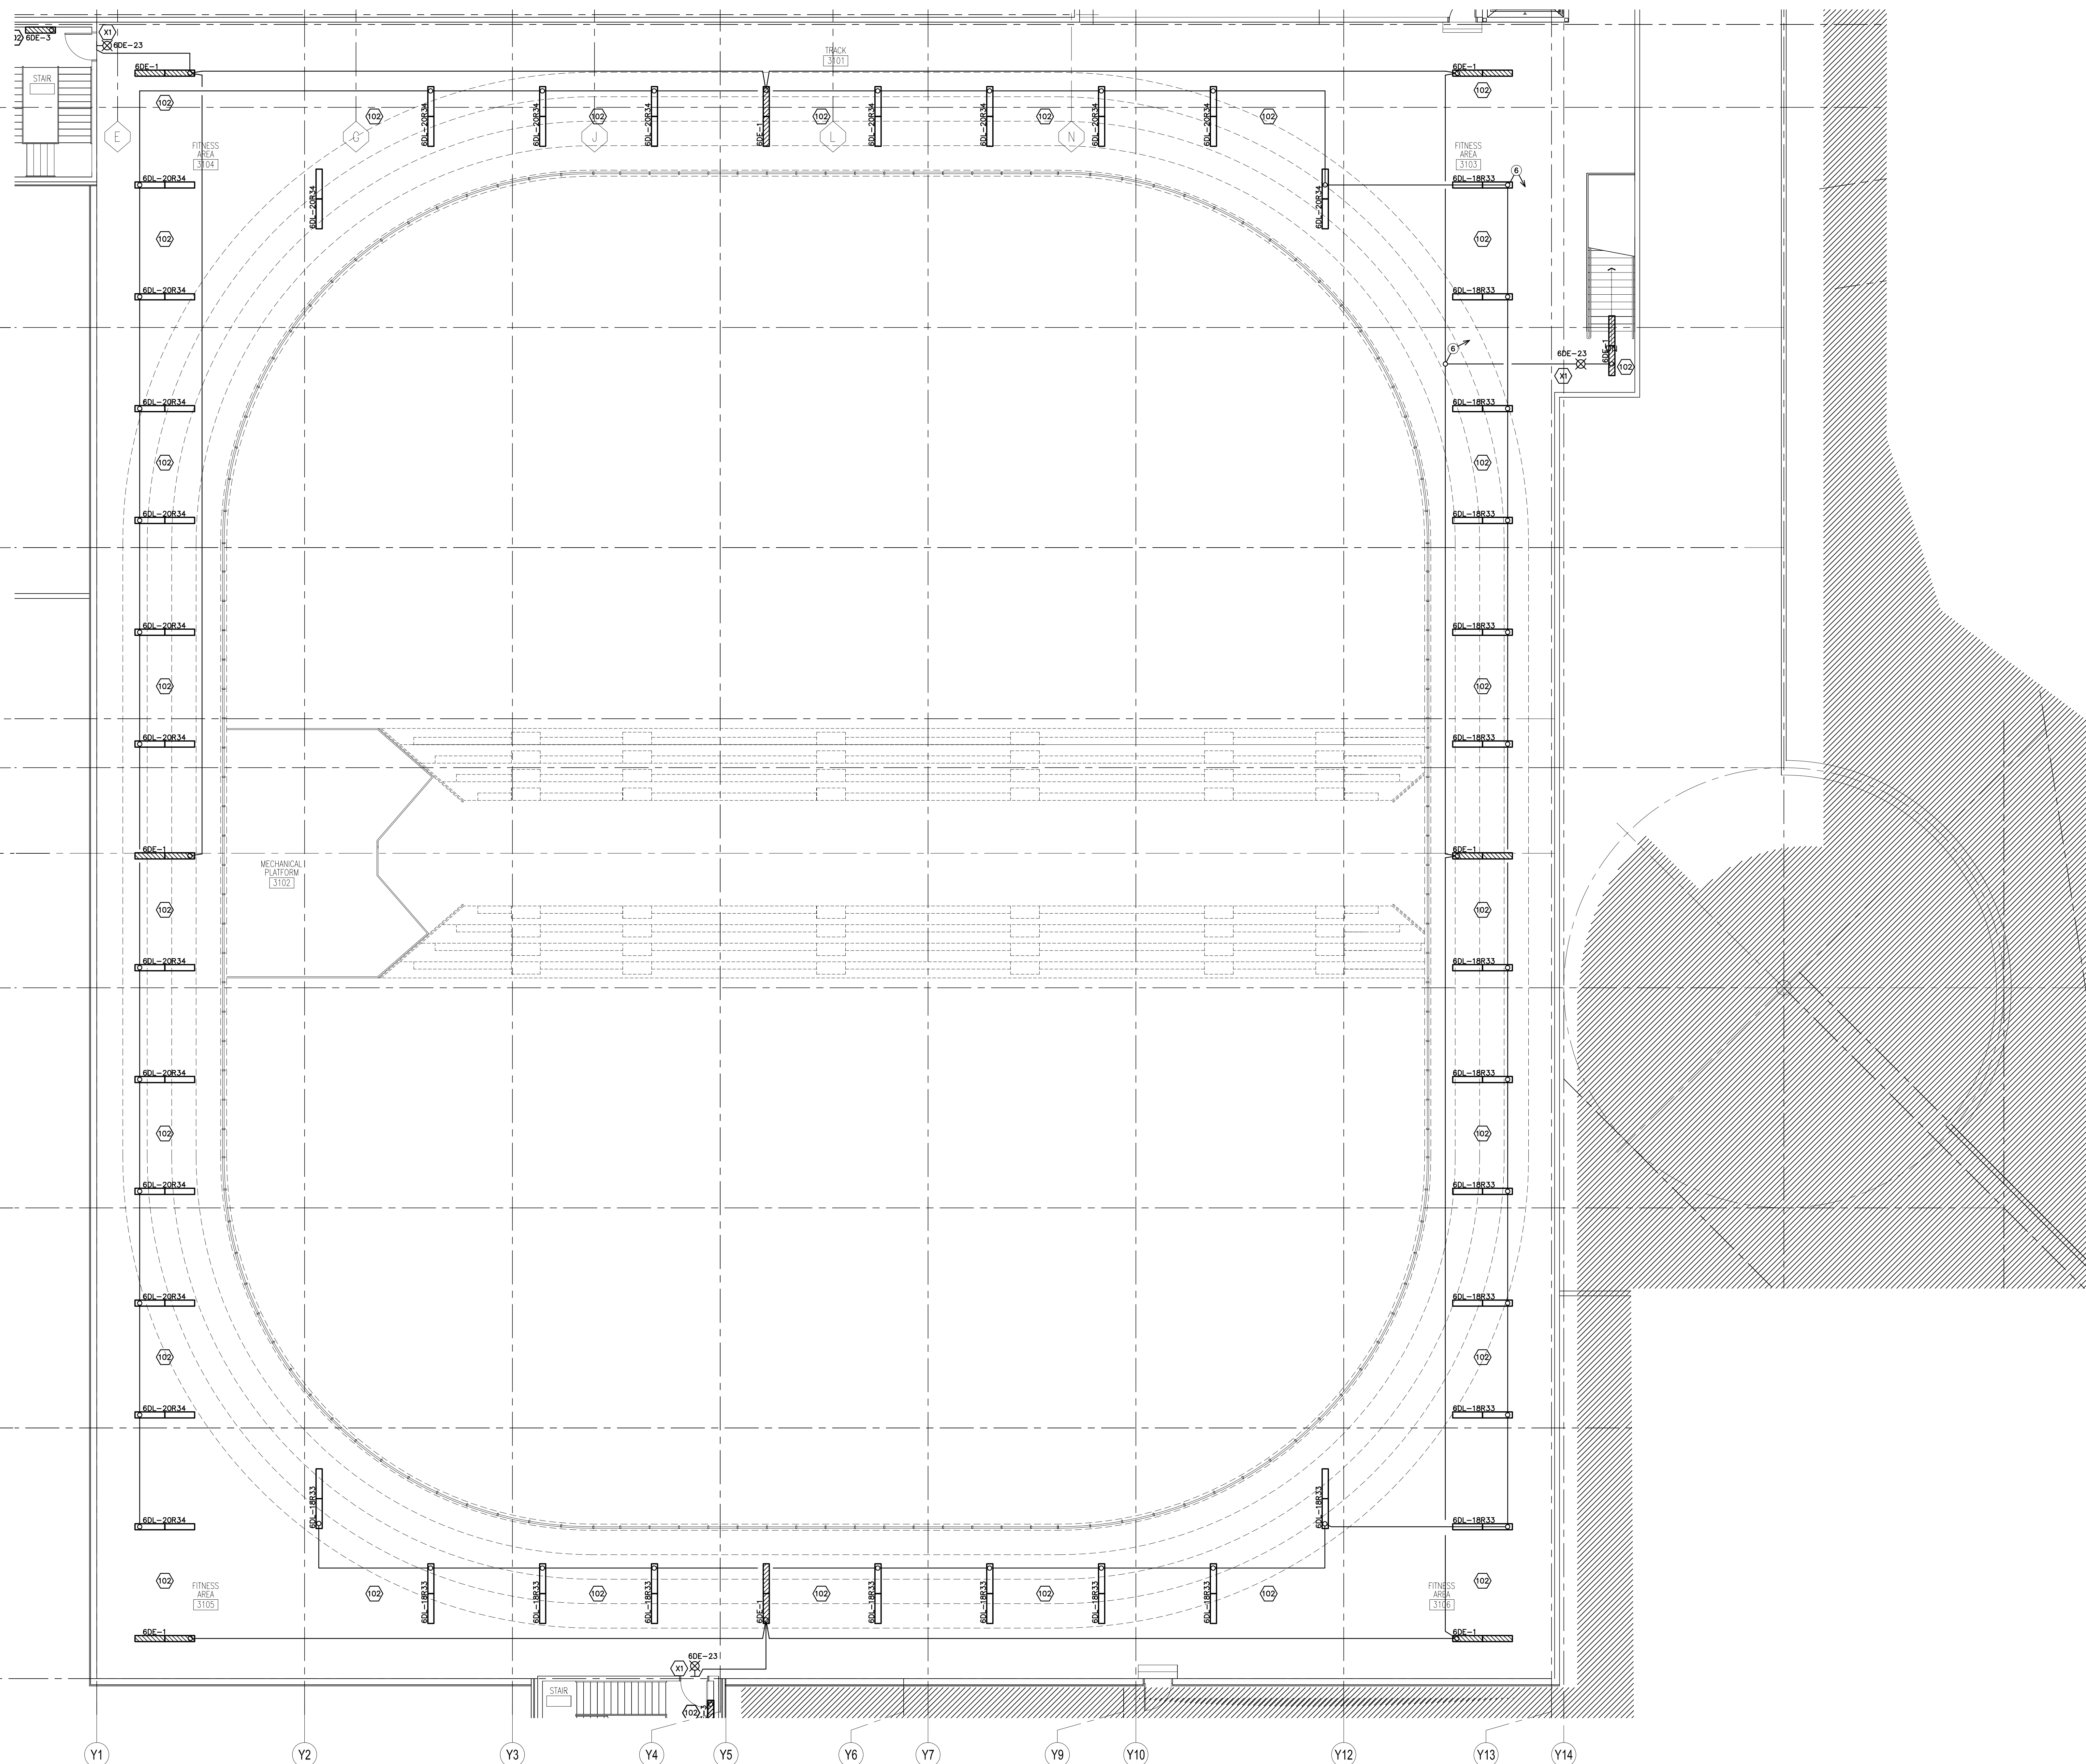


**KEYNOTES:**

- ← ① — 19C, 2#12 TO LVRC / PANEL
- ← ② — 19C, 4#12 TO LVRC / PANEL
- ← ③ — 19C, 6#12 TO LVRC / PANEL
- ← ④ — 19C, 8#12 TO LVRC / PANEL
- ← ⑤ — 25C, 10#12 TO LVRC / PANEL
- ← ⑥ — 25C, 12#12 TO LVRC / PANEL

**NOTES:**

1. REFER TO DRAWING E100 FOR ELECTRICAL SYMBOL LEGEND.
2. REFER TO DRAWING E400 FOR LUMINAIRE AND LOW VOLTAGE RELAY CONTROL SCHEDULES.
3. COORDINATE LOCATION OF ALL OCCUPANCY SENSORS ON SITE WITH ENGINEER PRIOR TO INSTALLATION. LOCATIONS SHOWN ARE FOR REFERENCE PURPOSES ONLY.
4. COORDINATE ALL LUMINAIRE MOUNTING HEIGHTS ON SITE WITH ARCHITECTURAL DETAILS AND MECHANICAL/STRUCTURAL COMPONENTS.
5. ALL LUMINAIRES INCLUDING EXIT SIGNAGE AND EMERGENCY LIGHTING LOCATED IN FIELD HOUSE TO HAVE WIREGUARDS.

HATCHED AREA DENOTES NOT IN CONTRACT FOR T9

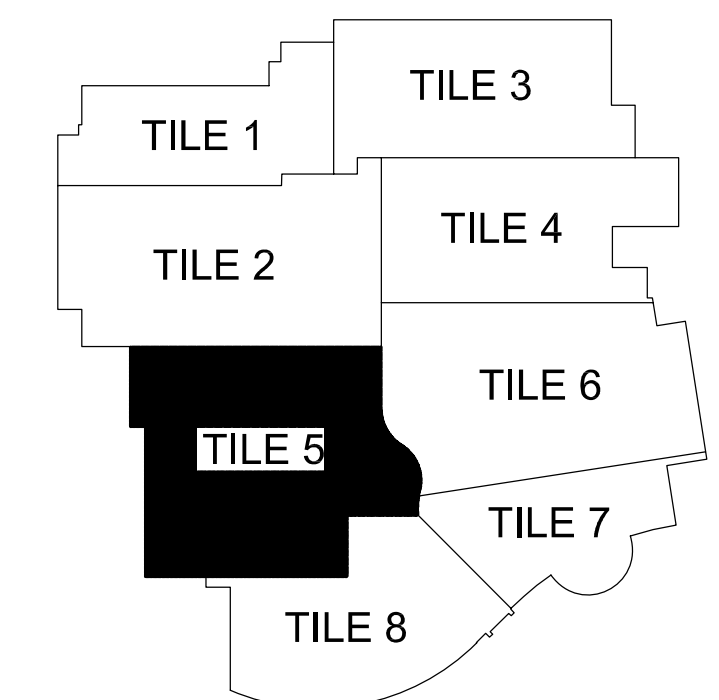

KEYPLAN



**MACDONALD ISLAND REDEVELOPMENT PROJECT**  
FORT McMURRAY, ALBERTA

TENDER PACKAGE  
PHASE ONE NEW CONSTRUCTION  
**T9**

**BARR RYDER**  
ARCHITECTS & PLANNERS

REGIONAL MUNICIPALITY OF WOOD BUFFALO  
**Stuart Olson**

**EarthTech**  
A Tyco International Ltd. Company

SEAL / PERMIT

REVISIONS		
NO	DATE	DESCRIPTION
1	June, 12/06	ISSUED FOR TENDER PACKAGE T9

SHEET TITLE <b>THIRD FLOOR LIGHTING PLAN TILE 5</b>		
Project No. 88604	Drawn MD	Checked MES
Scale 1:100	Date FEBRUARY, 2006	Sheet No. <b>E-217</b>